


SIXTH FLOOR PLAN
 (Proposed)
 (SCALE: 1:100)



TERRACE FLOOR PLAN
 (SCALE: 1:100)

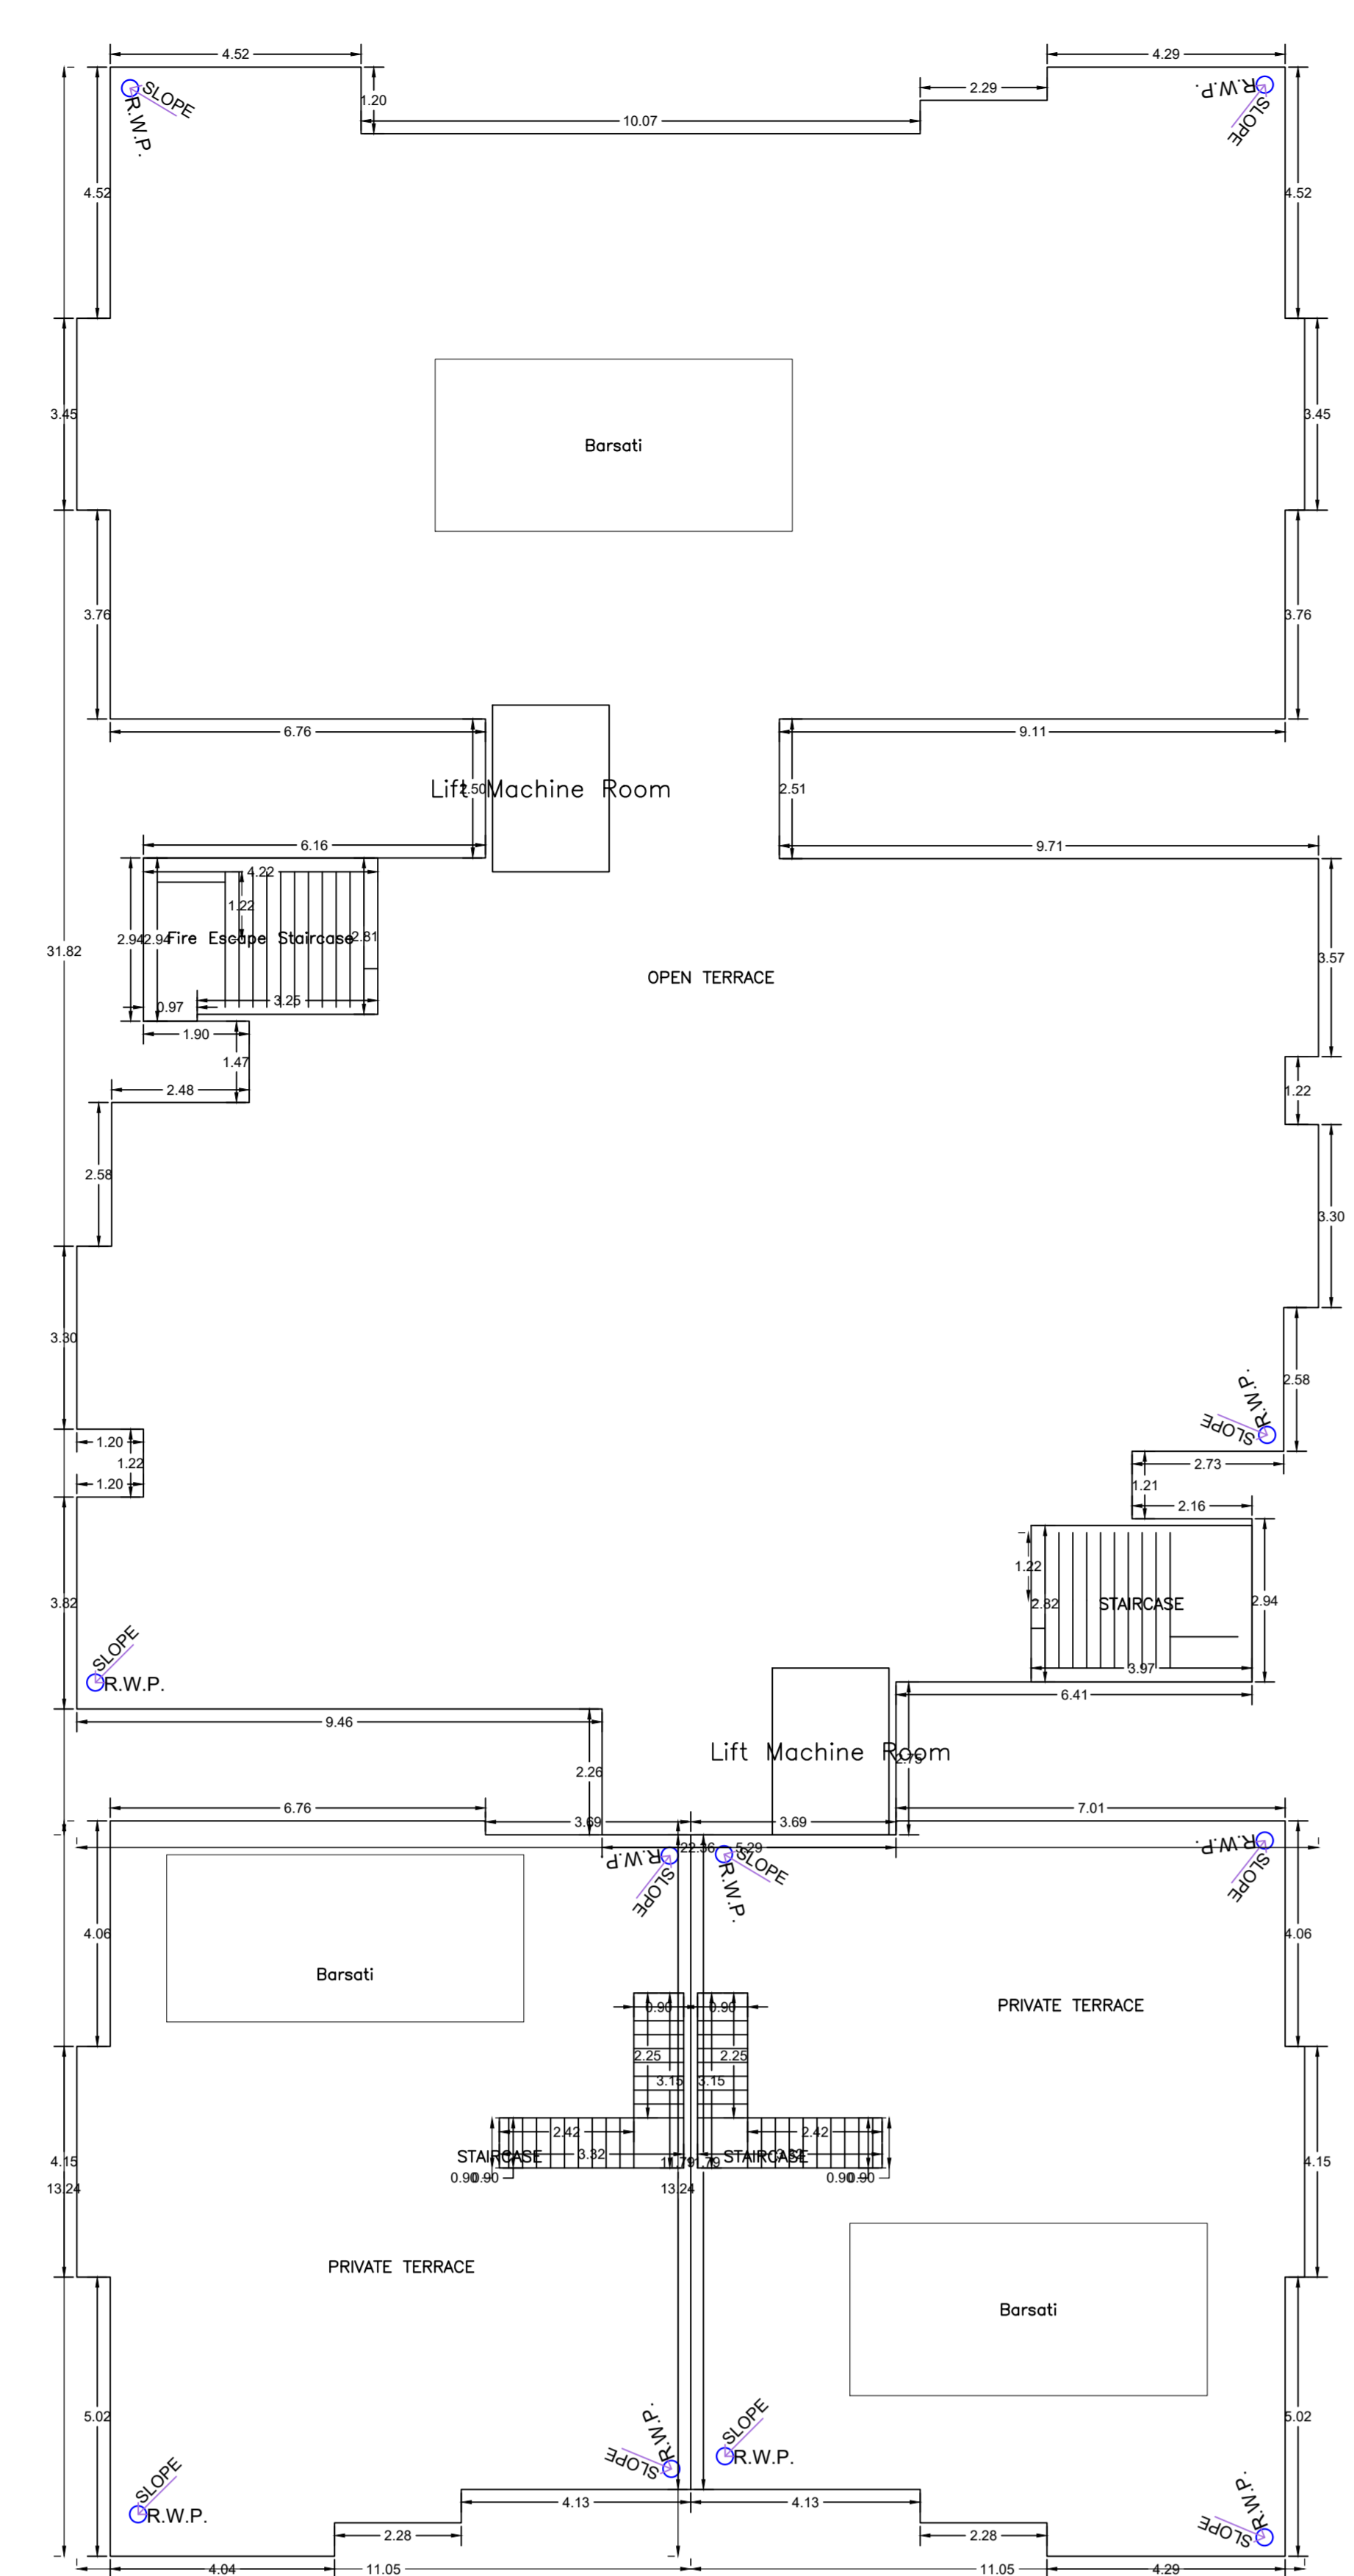

SECTION X-X


SECTION Y-Y




FRONT ELEVATION




SIDE ELEVATION

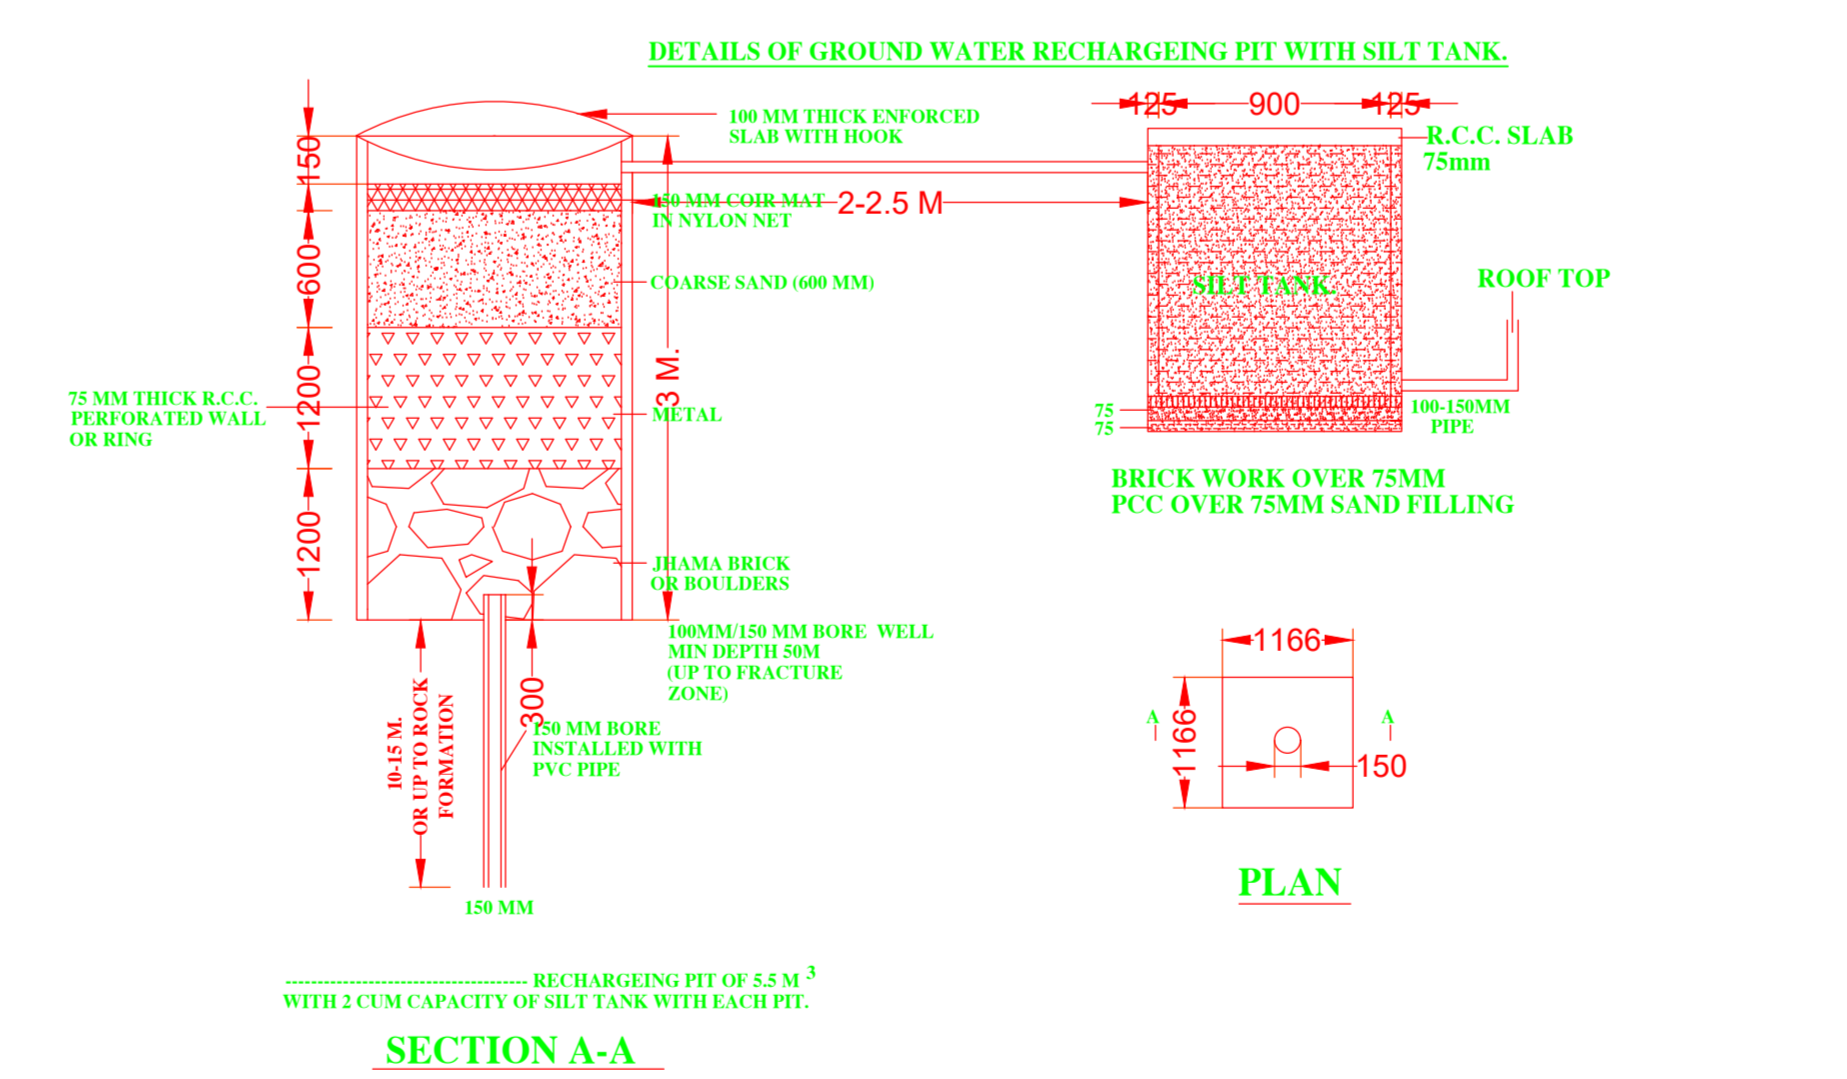

DESIGN OF RECHARGE PIT FOR ROOF TOP RAIN WATER HARVESTING

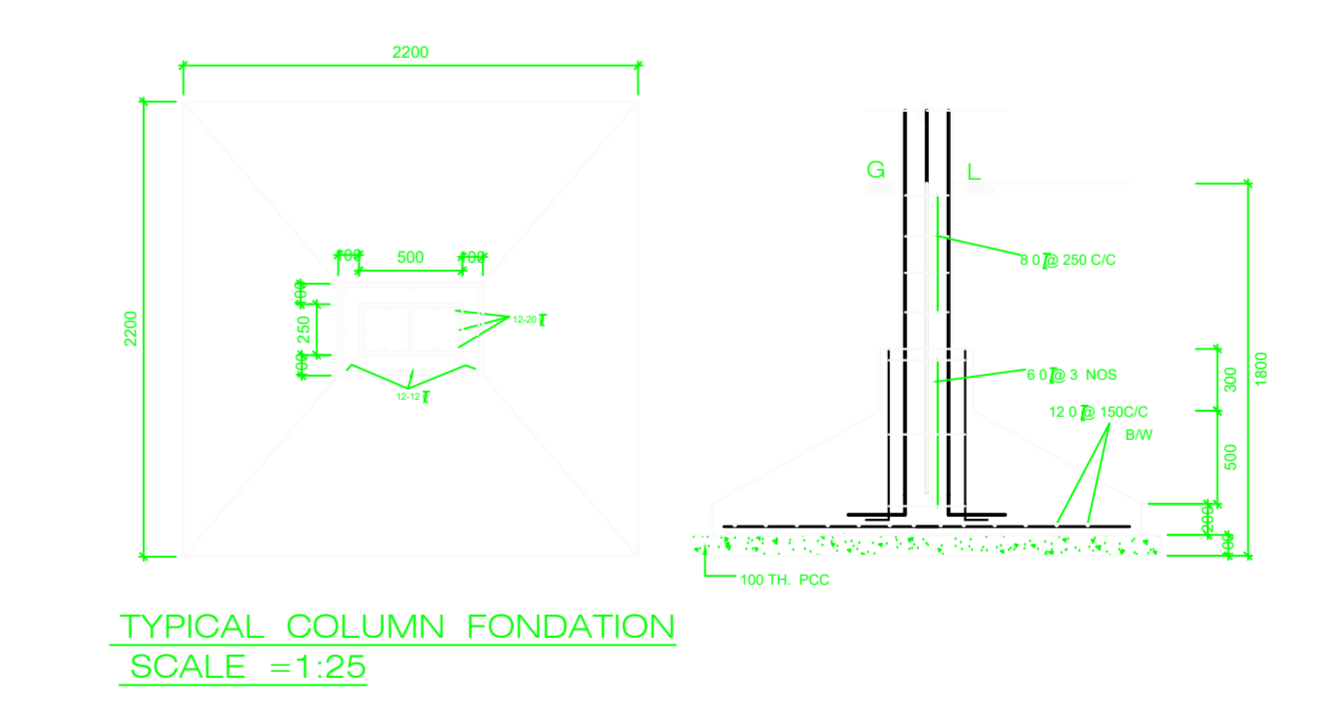

TYPICAL COLUMN FOUNDATION
 SCALE = 1:25

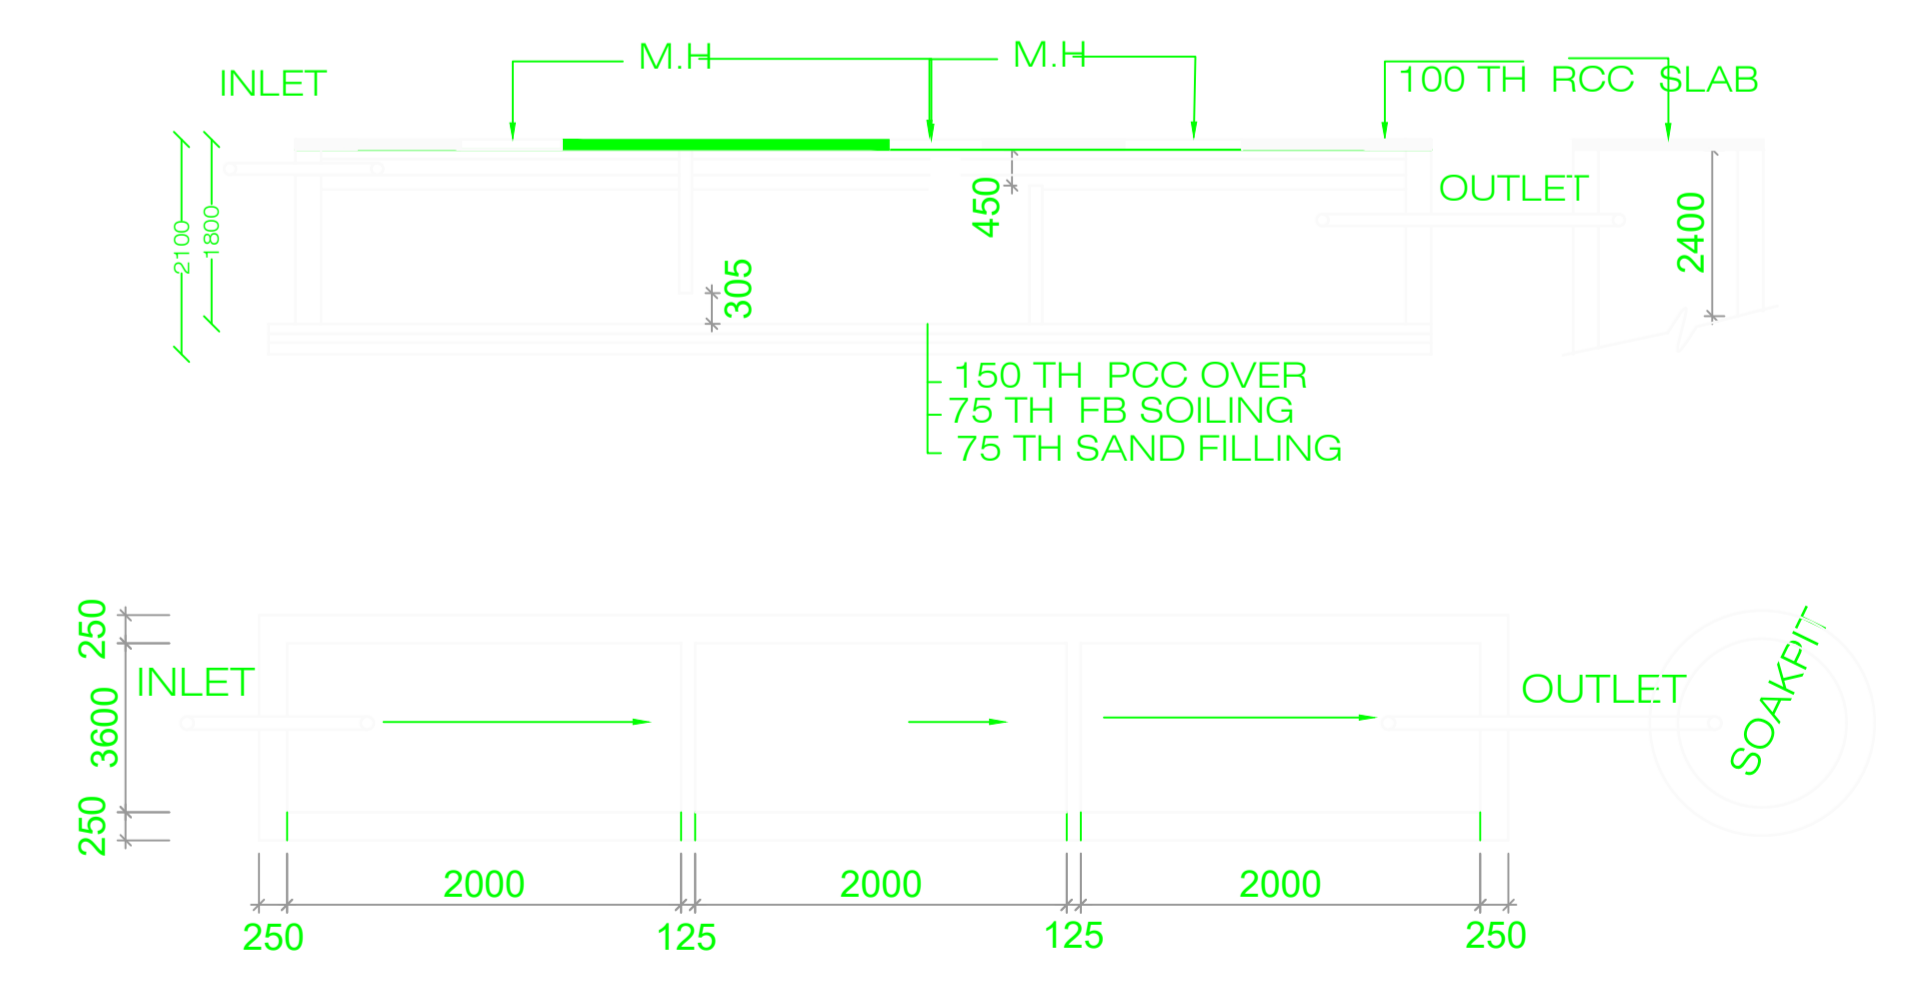

DETAIL OF SEPTIC TANK
 (SCALE=1:100)